


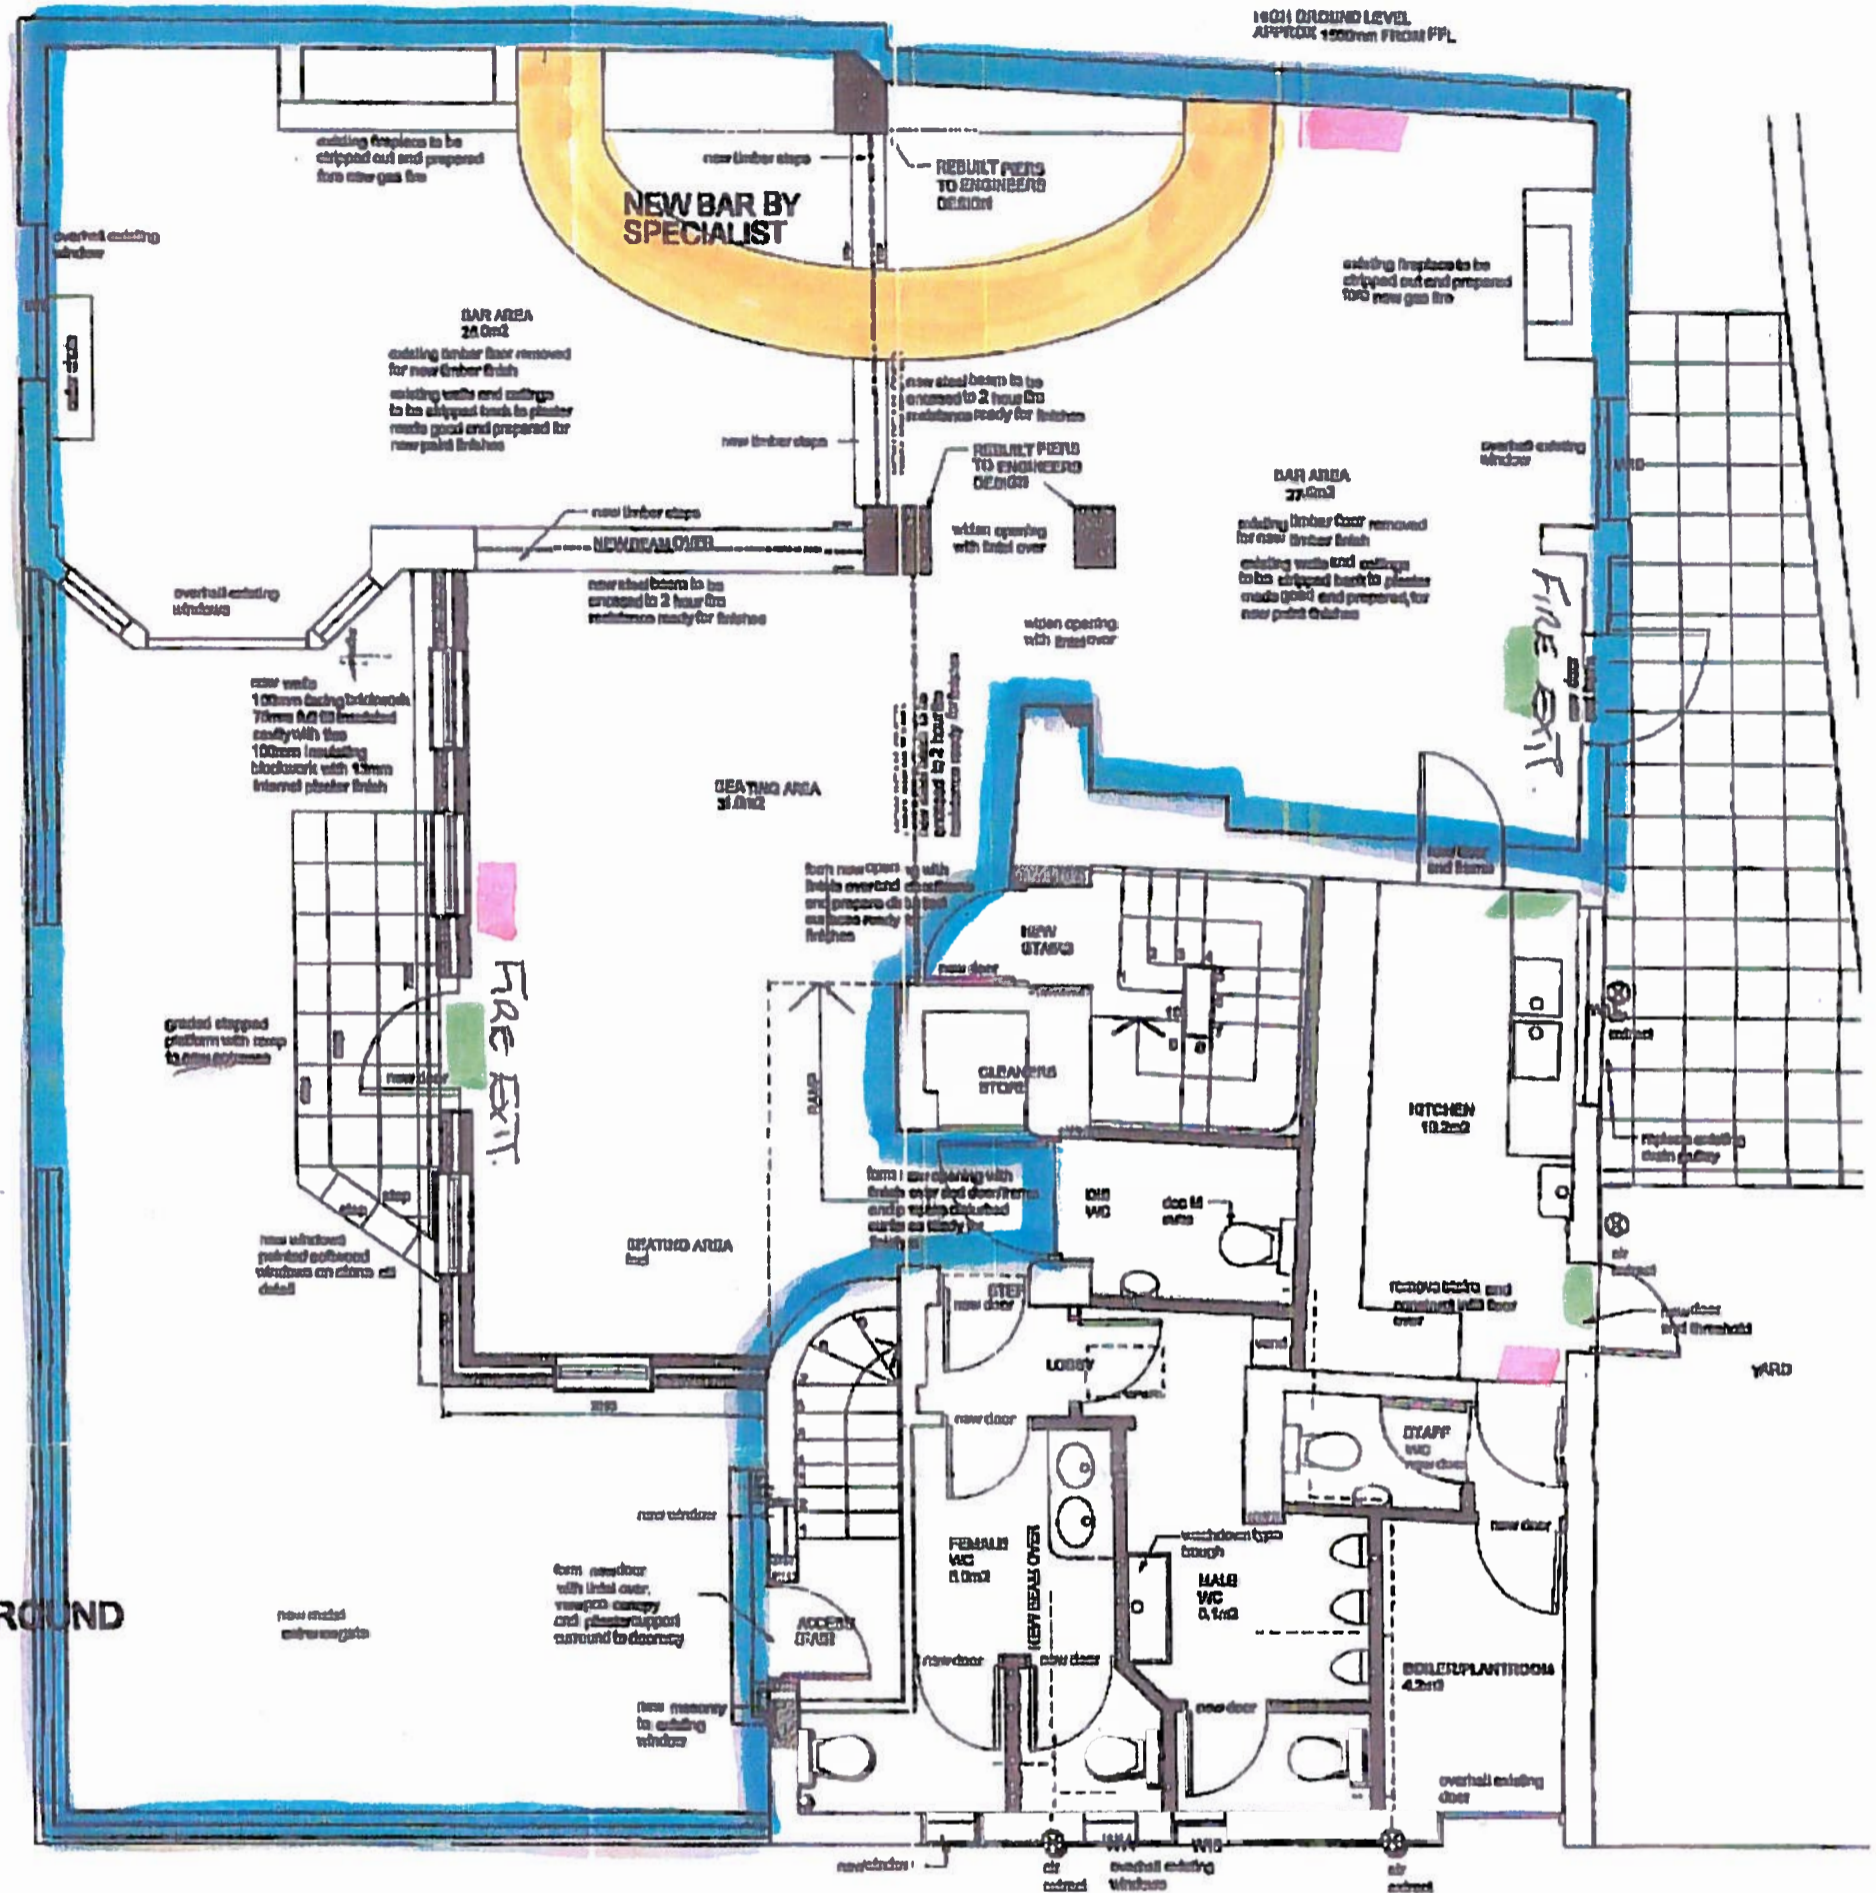


 FIRE EXTINGUISHERS / BLANKETS

 FIRE EXTING LIGHTING

 BAR COUNTER

 AREA OF ALCOHOL CONSUMPTION / ACTIVITIES



PROPOSED GROUND FLOOR PLAN
SCALE 1:50

